
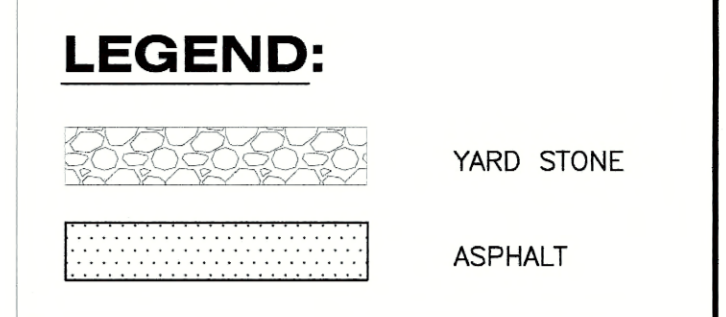
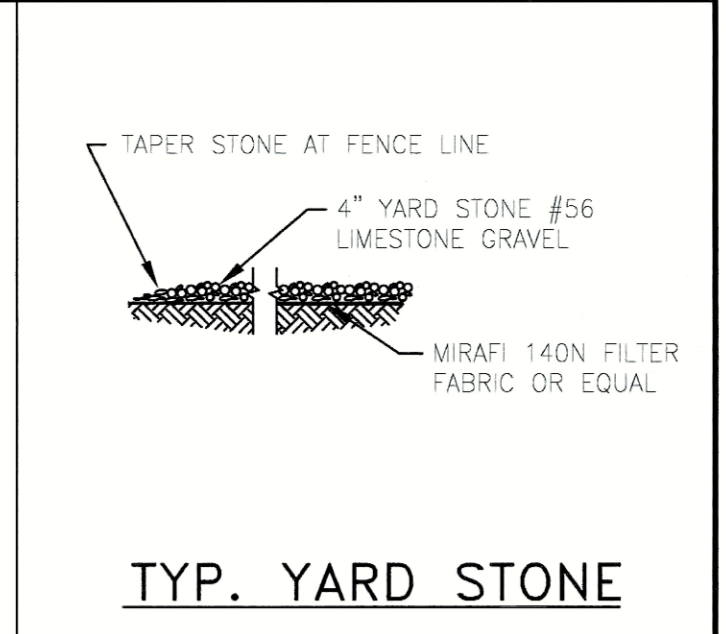
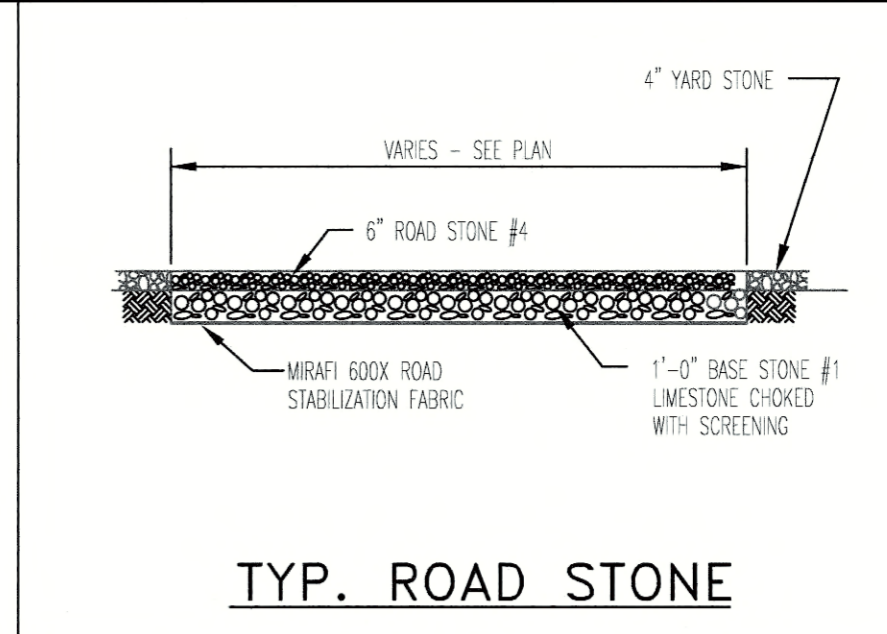


STATION
N

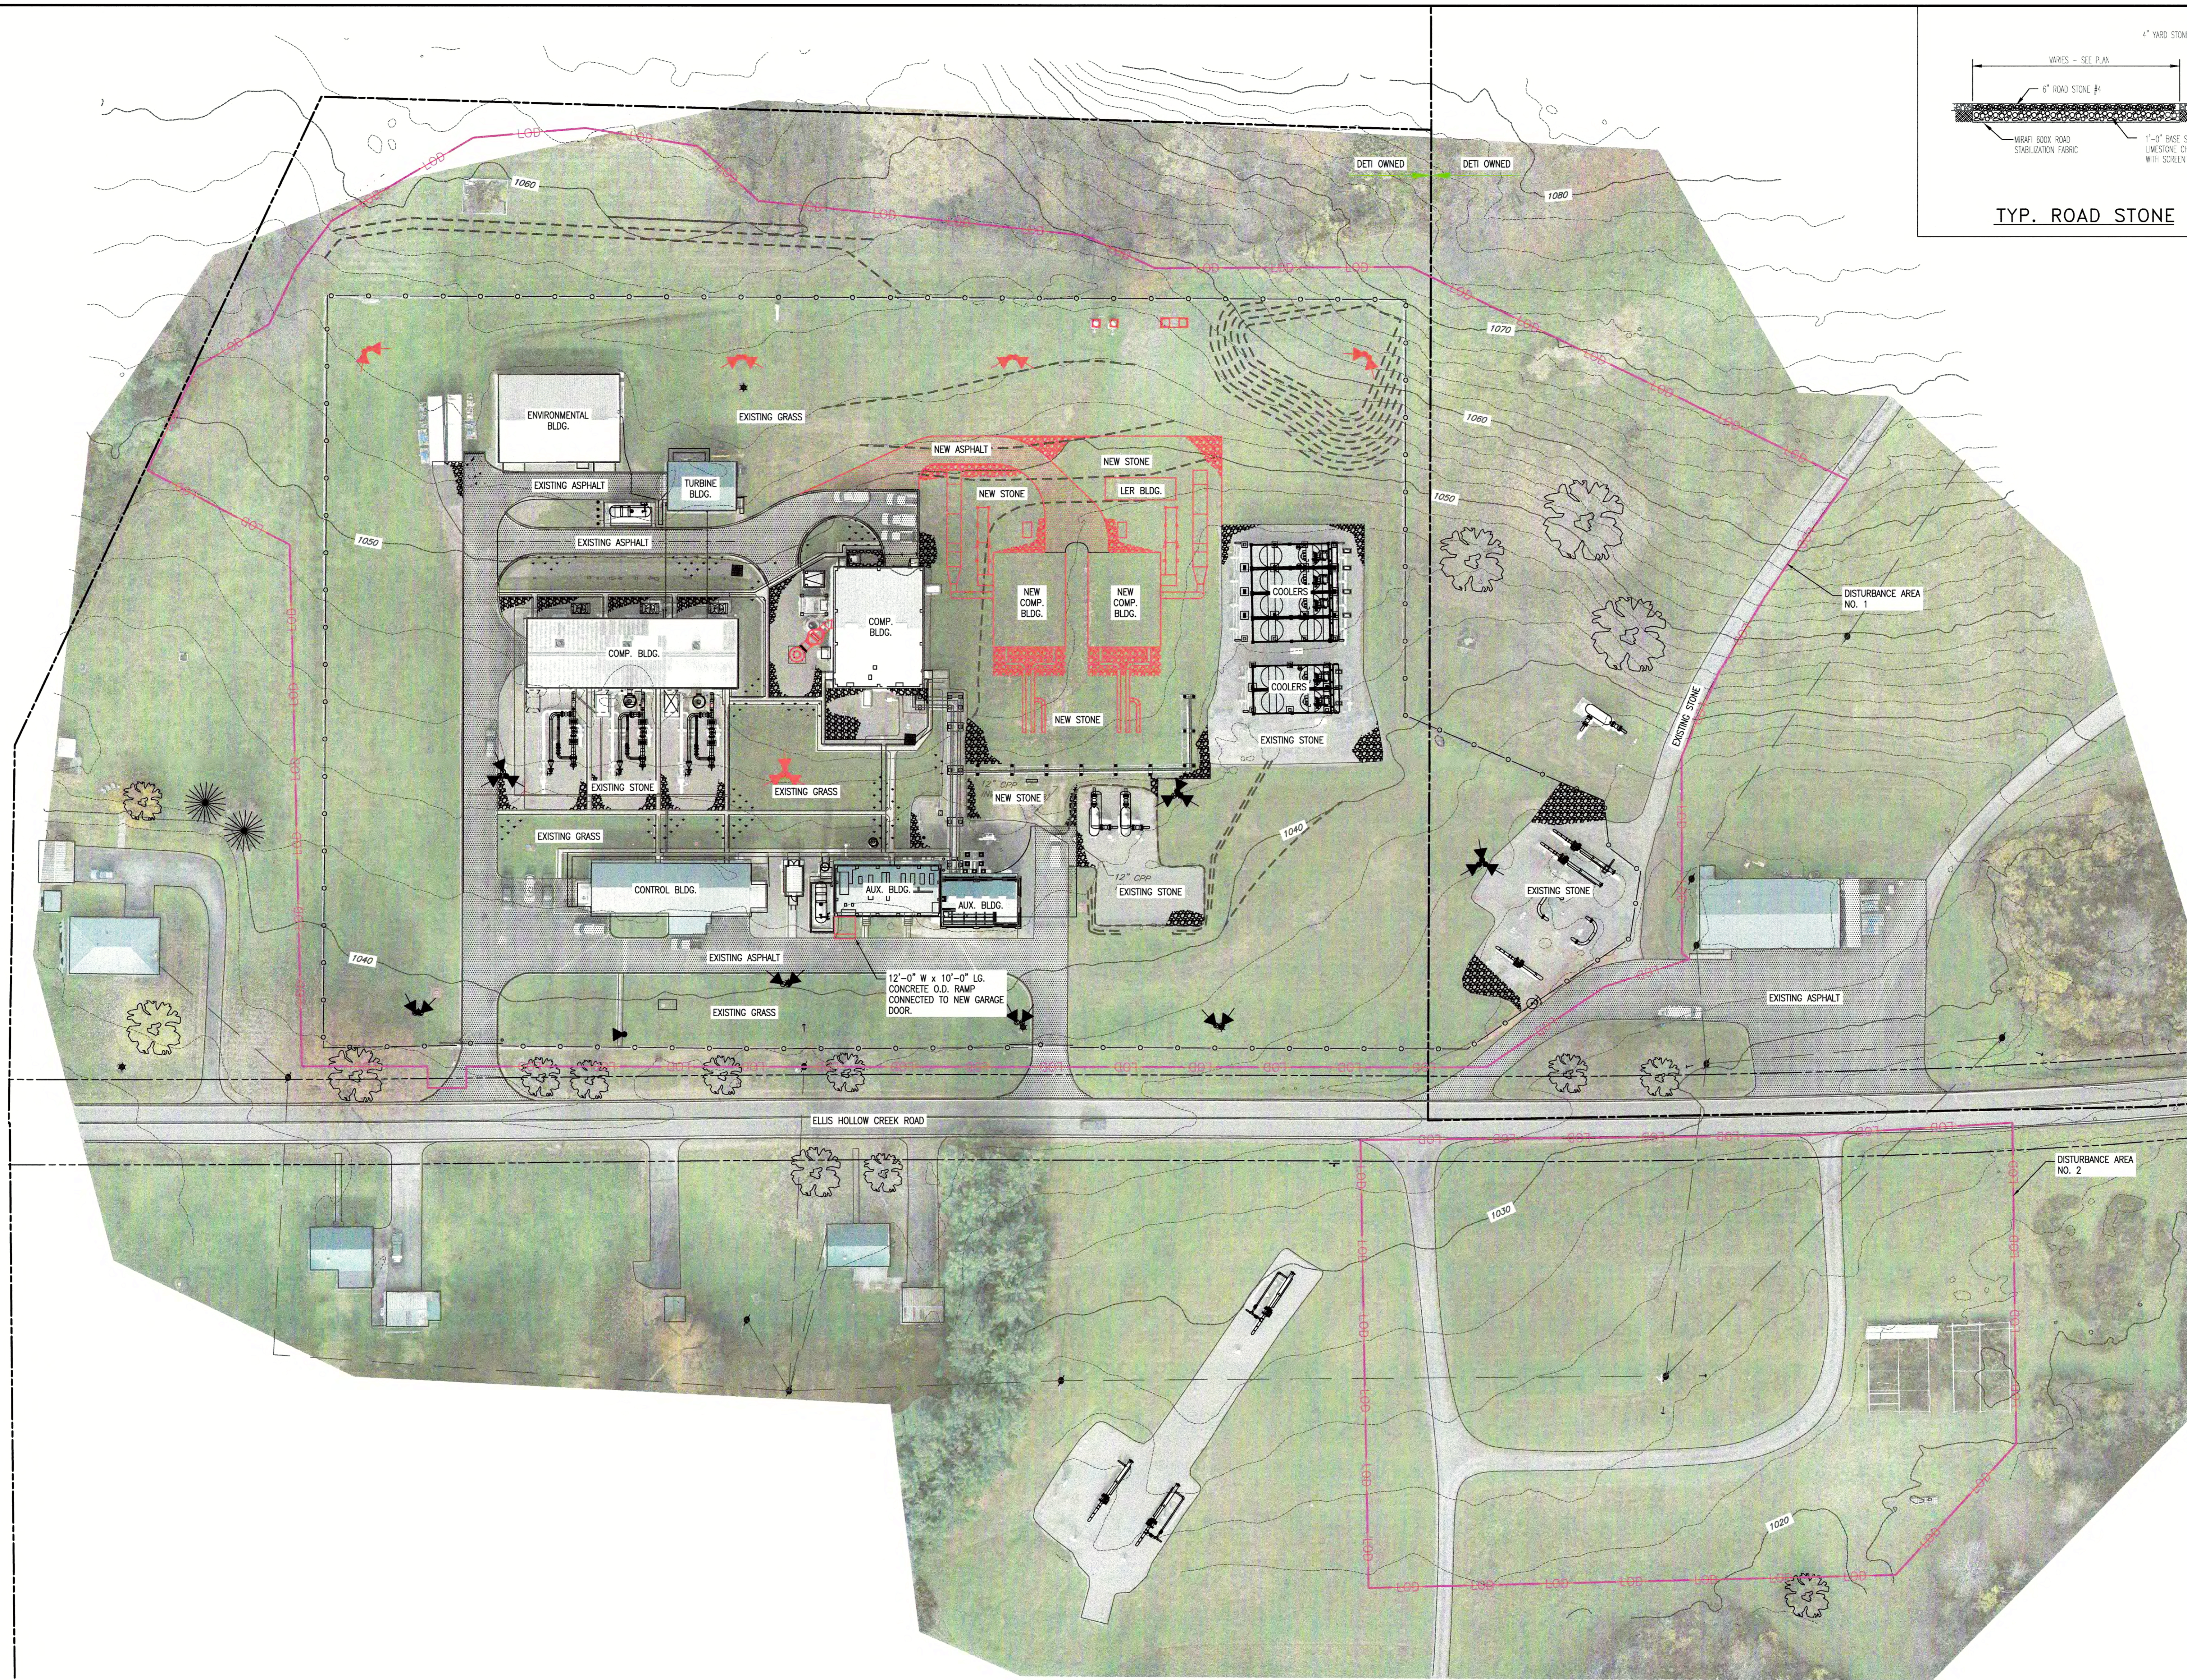

CONTROL POINTS


HORIZONTAL CONTROL: NORTHEAST CORNER OF EXIST. COMPRESSOR BUILDING FDN.
N 2+90.00
W 4+00.33

DISTURBANCE SUMMARY TABLE	
DISTURBANCE AREA	TOTAL ACREAGE
NO. 1 (COMPRESSOR DEVELOPMENT)	9.21 ACRES
NO. 2 (LADOWN AND STORAGE AREA)	2.17 ACRES
TOTAL	11.38 ACRES

* NO EXISTING TREES ARE TO BE DISTURBED

EARTHWORK

SITE WORK CUT = 243 CU. YARDS
SITE WORK FILL = 243 CU. YARDS
OVERFLOW DRAIN CUT = 1449 CU. YARDS
STOCKPILE FILL = 1449 CU. YARDS

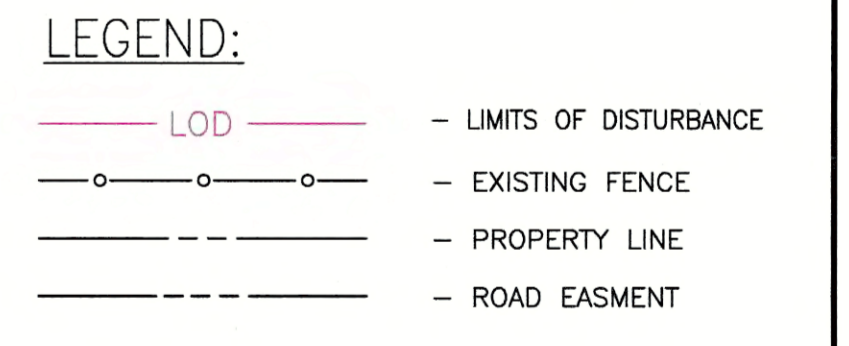

PLAN VIEW

ISSUED FOR
4/13/2020
PERMITTING





SYM.	DATE	BY	REVISION INFORMATION	PROJECT/TASK	APP.	SEAL
Δ	04/13/20	JLB	ISSUED FOR PERMITTING	39014.1.3		
Δ	03/17/20	JLB	ISSUED FOR INFORMATION	78567.3.6281		
Δ	03/06/20	JLB	ISSUED FOR INFORMATION	78567.3.6281		

ORIGINAL CONSTRUCTION INFORMATION		PROJECT/TASK		FOR	
PROJECT/TASK:	39014.1.3	PROJECT/TASK:	39014.1.3	FOR:	BORGER COMPRESSOR STATION (HUB II)
DRAWN:	JLB	DATE:	01-09-20	TITLE:	LOD
CHECKED:		TOWN:	DRYDEN	COUNTY:	TOMPKINS, NY
APP. FOR BID:		GROUP:		DWG. NO.:	
APP. FOR CONST.:		DR/FILE:	I:\2100S\2183\Drawings	REV.:	
SCALE:	1" = 40'				

BASIC SYSTEMS, INC.
707 East Main St., Richmond, Virginia 23219
8255 CADIZ ROAD
CAMBRIDGE, OHIO 43725
(740) 432-3001

Dominion Transmission, Inc.
707 East Main St., Richmond, Virginia 23219

STATION
N

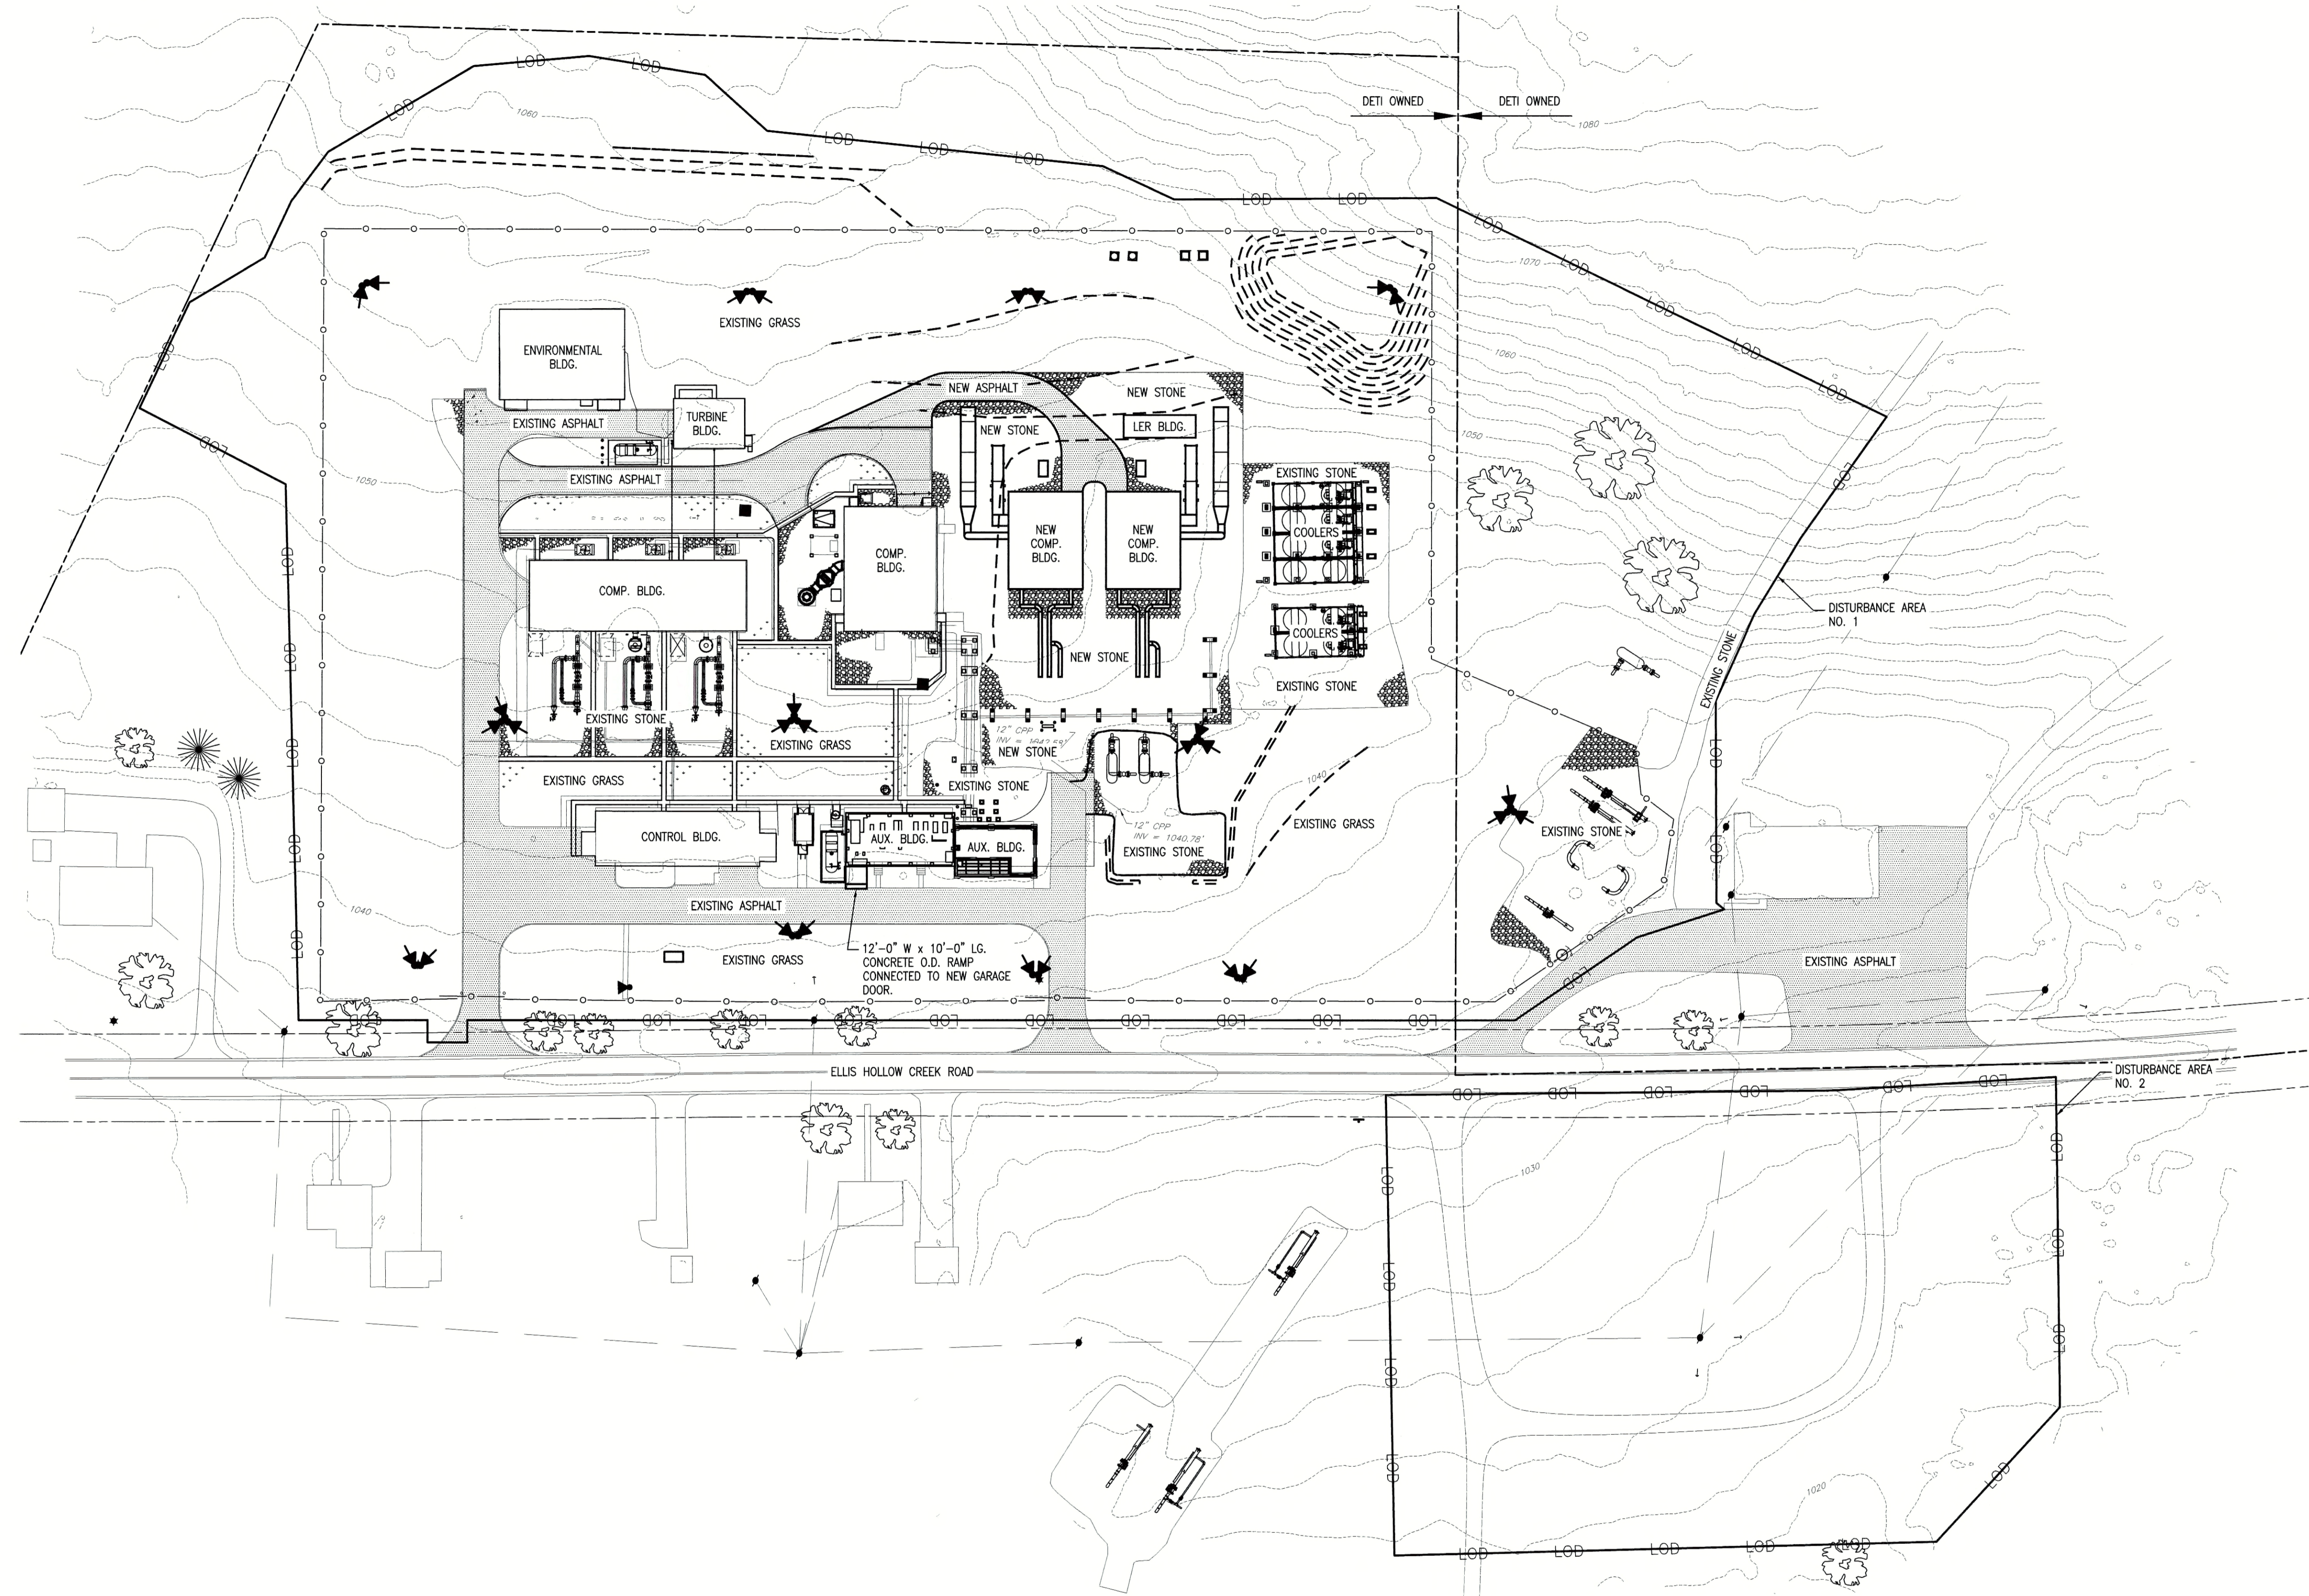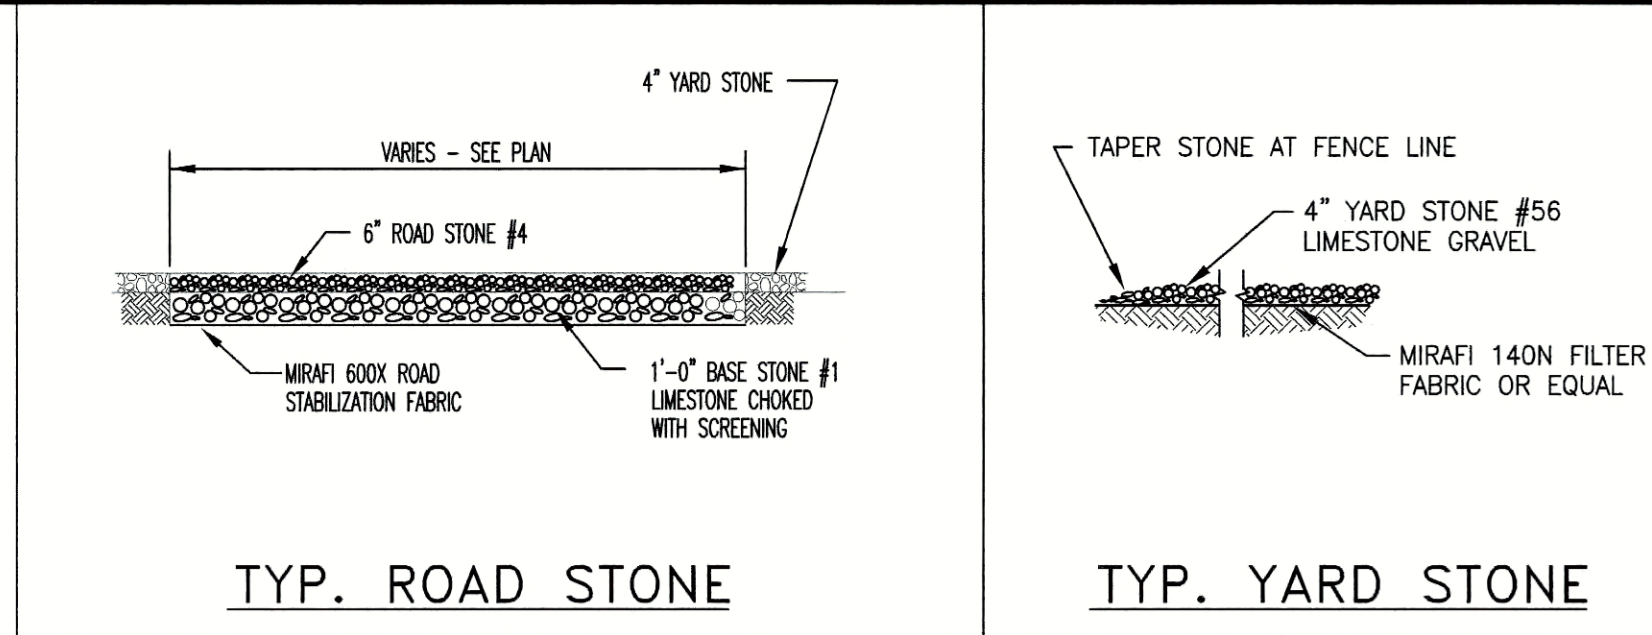

LEGEND:

YARD STONE
 ASPHALT

CONTROL POINTS

HORIZONTAL CONTROL NORTHEAST CORNER OF EXIST. COMPRESSOR BUILDING FDN.
 N 2+90.00
 W 4+00.33

DISTURBANCE SUMMARY TABLE

DISTURBANCE AREA	TOTAL ACREAGE
NO. 1 (COMPRESSOR DEVELOPMENT)	9.21 ACRES
NO. 2 (LAYDOWN AND STORAGE AREA)	2.17 ACRES
TOTAL	11.38 ACRES

* NO EXISTING TREES ARE TO BE DISTURBED

EARTHWORK

SITE WORK CUT = 243 CU. YARDS
 SITE WORK FILL = 243 CU. YARDS
 DIVERSION DRAIN CUT = 1449 CU. YARDS
 STOCKPILE FILL = 1449 CU. YARDS

LEGEND:

- LIMITS OF DISTURBANCE
 - EXISTING FENCE
 - PROPERTY LINE
 - ROAD EASMENT

PLAN VIEW

SCALE 1"=50'

ISSUED FOR
4/13/2020
PERMITTING



SYM.	DATE	BY	REVISION INFORMATION	PROJECT/TASK	APP.	SEAL
△	04/13/20	jl	ISSUED FOR PERMITTING	78576.3.6291		
△	03-17-20	mh	ISSUED FOR INFORMATION	78576.3.6291		
△	03-06-20	mh	ISSUED FOR INFORMATION	78576.3.6291		
△	03-08-10	JA	TOWN OF DRYDEN REVIEW COMMENTS			

ORIGINAL CONSTRUCTION INFORMATION		FOR:	
PROJECT/TASK:	39014.1.3	BORGER COMPRESSOR STATION (HUB II)	
DRAWN:	JLA 12-15-09	TITLE: PROPOSED LOD AND SITE PLAN	
CHECKED:	KAH 12-15-09	TOWN:	DRYDEN COUNTY: TOMPKINS, NY
APP. FOR BID:		GROUP:	PD
APP. FOR CONST.:		OWG. NO.:	E7464G
SCALE:	AS NOTED	REV.:	4

BASIC SYSTEMS, INC.
 8256 CADIZ ROAD
 CAMBRIDGE, OHIO 43725
 (740) 432-3001

Dominion Transmission, Inc.
 707 East Main St. Richmond, Virginia 23219